


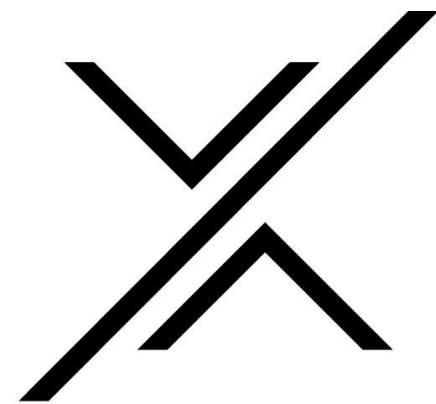

NSD
FOODSERVICE
CONSULTANTS
NEXT STEP DESIGN
913 West Street Annapolis, MD 21401
Ph: (410) 263-1200
nextstepdesign.com


ISSUE	DATE
SD	11/15/21
50% DD	12/22/21

DATE: 11/23/21 SCALE: 1/4" = 1'-0"

PROJECT #: - DRAWN: EGM

FOODSERVICE EQUIPMENT
FLOOR PLAN - AREA 9.0 -
DAYCLUB


SHEET #:
FS-9.0-DC 1.1

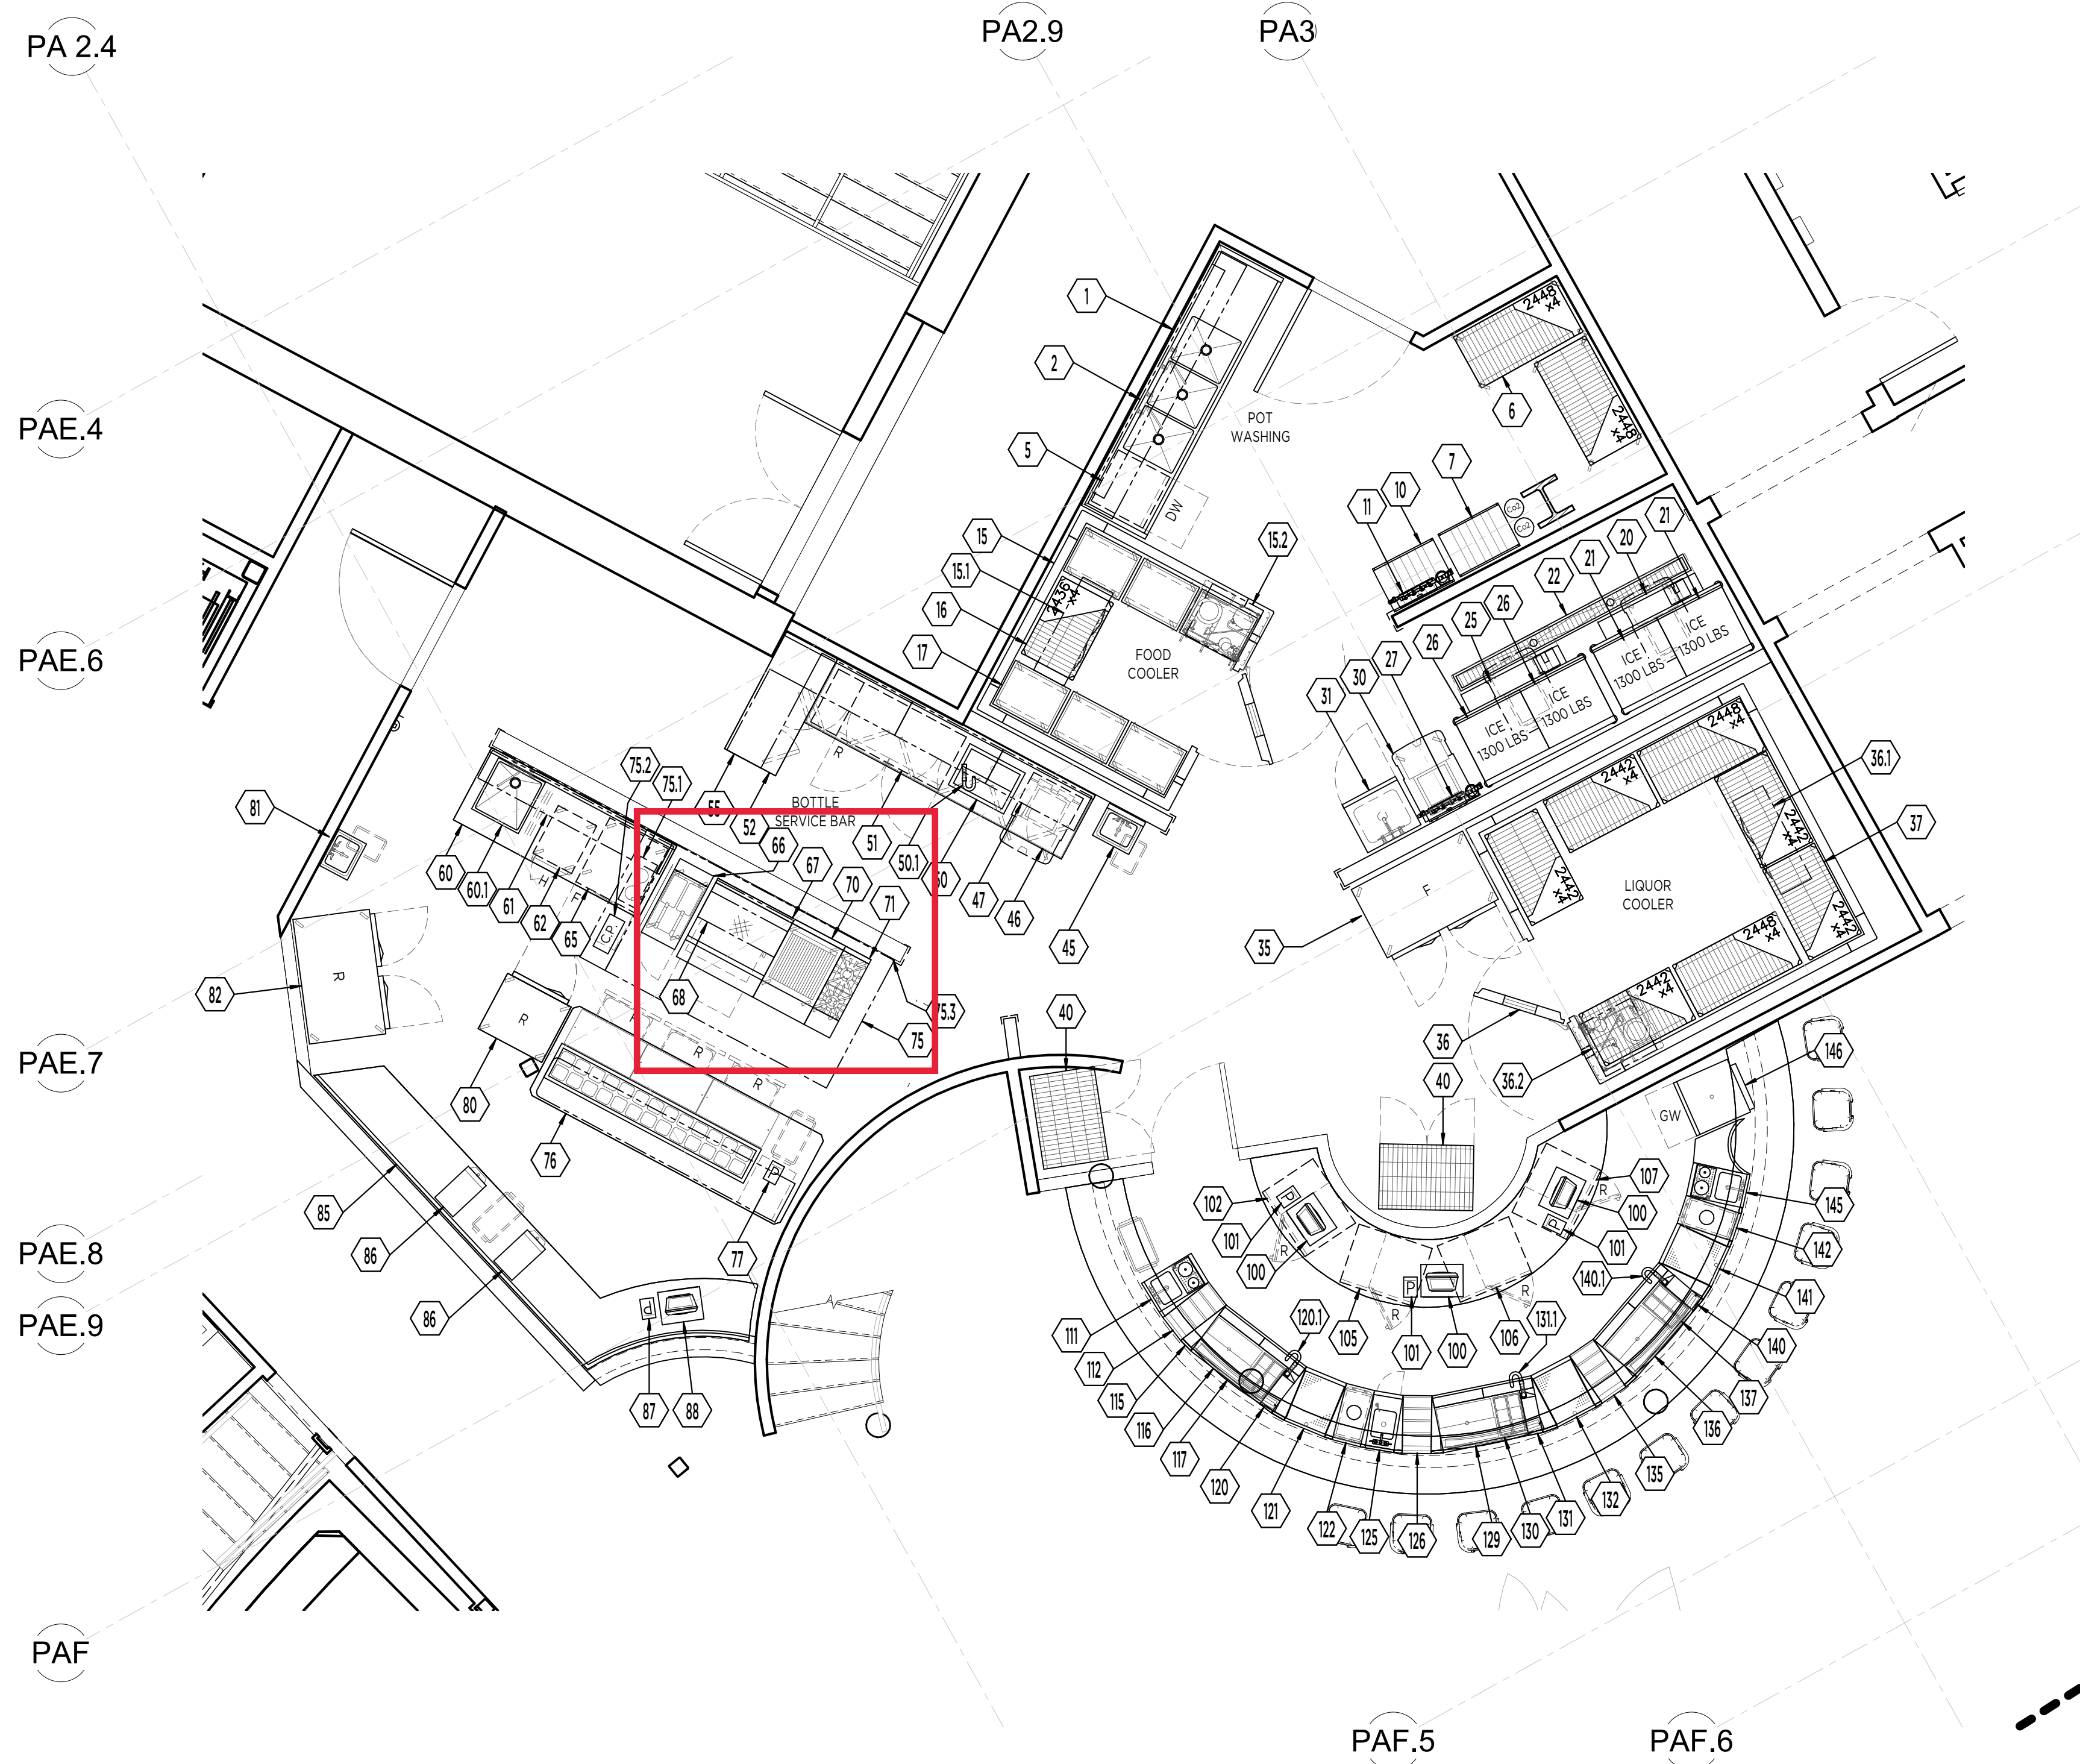

LEVEL 9 - TACO STAND

AREA 9.0 - DAY CLUB
1/4" = 1'-0"

EQUIPMENT FLOOR PLAN

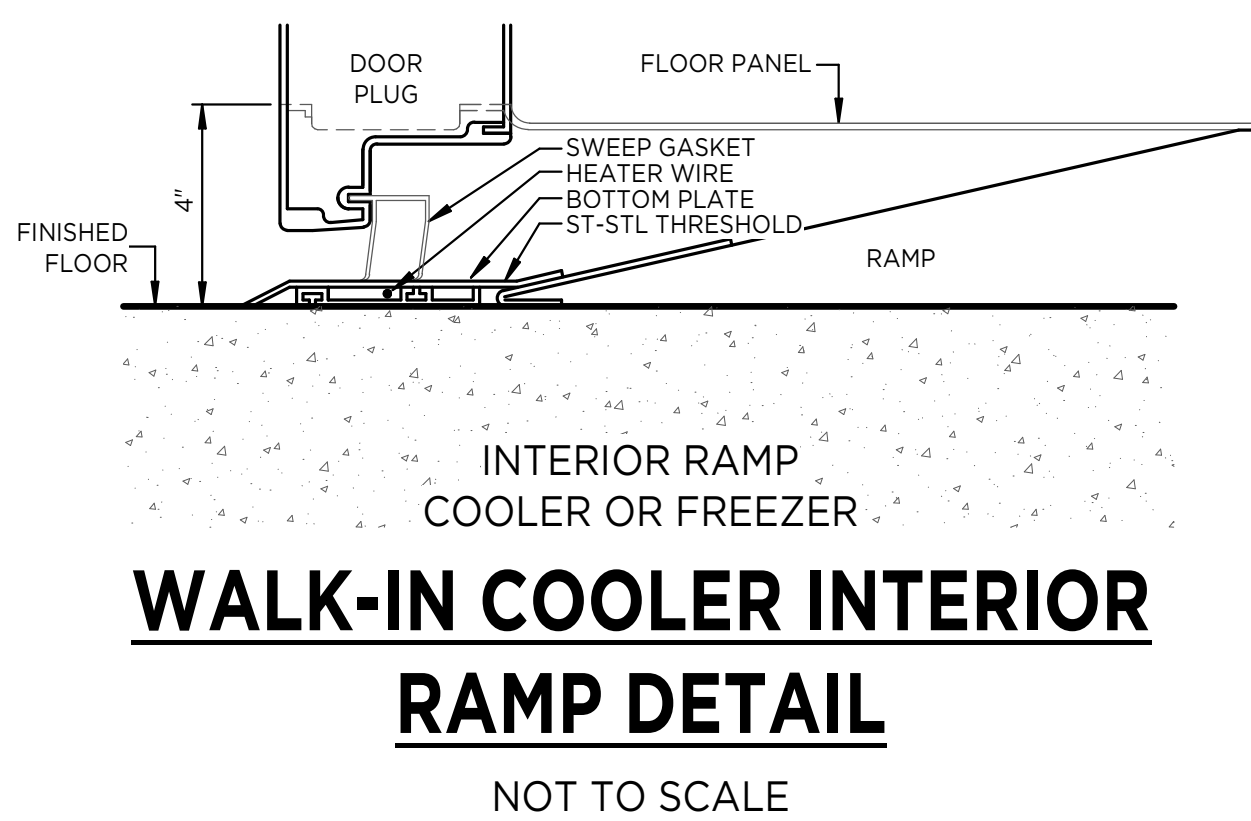

COPYRIGHT®
UNAUTHORIZED USE OF THE FOODSERVICE DESIGN, DETAILS, AUTOCAD BLOCKS, REVIT FAMILIES, AND SPECIFICATIONS CONTAINED IN THESE DOCUMENTS IS STRICTLY PROHIBITED. NSD INC. MAINTAINS OWNERSHIP OF SAME. THIS PROHIBITION EXTENDS FROM PRINTED MATERIAL TO ANY ELECTRONIC VERSIONS OF THE SAME. NO USE, OTHER THAN THAT FOR WHICH IT IS INTENDED, IS STRICTLY PROHIBITED WITHOUT WRITTEN PERMISSION FROM NEXT STEP DESIGN, INC. ALL RIGHTS RESERVED.

EQUIPMENT SCHEDULE

PROJECT BLUE

PR	ITEM	QTY	SOURCE	DESCRIPTION
	1	1	FABRICATOR	THREE COMPARTMENT POT SINK
	2	1	FABRICATOR	WALL SHELF W/ POT RACK
	3	1	SPARE NUMBER	SPARE NUMBER
	4	1	SPARE NUMBER	SPARE NUMBER
	5	1	HOBART	DISHWASHER, UNDERCOUNTER
	6	2	METRO	STEM CASTER CART
(VEND)	7	1	BY VENDOR	SODA BAG-N-BOX SYSTEM
	8	1	SPARE NUMBER	SPARE NUMBER
	9	1	SPARE NUMBER	SPARE NUMBER
(VEND)	10	1	BY VENDOR	SODA BAG-N-BOX SYSTEM
	11	1	EVERPURE	WATER FILTER ASSEMBLY
	12	1	SPARE NUMBER	SPARE NUMBER
	13	1	SPARE NUMBER	SPARE NUMBER
	14	1	SPARE NUMBER	SPARE NUMBER
	15	1	THERMOKOOL	WALK-IN COOLER
	15.1	1	COLDZONE	EVAPORATOR COIL
	15.2	1	COLDZONE	CONDENSING UNIT, WATER COOLED
	16	1	METRO	WALK-IN SHELVING (LOT)
	17	6	NEW AGE	BUN PAN RACK, MOBILE
	18	1	SPARE NUMBER	SPARE NUMBER
	19	1	SPARE NUMBER	SPARE NUMBER
	20	1	FOLLETT	ICE BIN SHUTTLE SYSTEM
	20.1	1	SAN JAMAR	ICE SCOOP HOLDER
	21	2	HOSHIZAKI	ICE MAKER, CUBE STYLE
	22	1	IMC TEDDY	FLOOR TROUGH
	23	1	SPARE NUMBER	SPARE NUMBER
	24	1	SPARE NUMBER	SPARE NUMBER
	25	1	FOLLETT	ICE BIN SHUTTLE SYSTEM
	25.1	1	SAN JAMAR	ICE SCOOP HOLDER
	26	2	HOSHIZAKI	ICE MAKER, CUBE STYLE
	27	1	EVERPURE	WATER FILTER ASSEMBLY
	28	1	SPARE NUMBER	SPARE NUMBER
	29	1	SPARE NUMBER	SPARE NUMBER
	30	3	CAMBRO	ICE BIN, MOBILE
	31	1	ADVANCE TABCO	MOP SINK CABINET
	32	1	SPARE NUMBER	SPARE NUMBER
	33	1	SPARE NUMBER	SPARE NUMBER
	34	1	SPARE NUMBER	SPARE NUMBER
	35	1	TRAUlsen	FREEZER, REACH-IN
	36	1	THERMOKOOL	WALK-IN COOLER
	36.1	1	COLDZONE	EVAPORATOR COIL
	36.2	1	COLDZONE	CONDENSING UNIT, WATER COOLED
	37	1	METRO	WALK-IN SHELVING (LOT)
	38	1	SPARE NUMBER	SPARE NUMBER
	39	1	SPARE NUMBER	SPARE NUMBER
	40	2	METRO	SECURITY UNIT
	41	1	SPARE NUMBER	SPARE NUMBER
	42	1	SPARE NUMBER	SPARE NUMBER
	43	1	SPARE NUMBER	SPARE NUMBER
	44	1	SPARE NUMBER	SPARE NUMBER
	45	1	IMC TEDDY	HAND SINK
(OWN)	45.1	1	BY OWNER	SOAP & TOWEL DISPENSER
	46	1	FABRICATOR	BEVERAGE COUNTER
	47	3	FABRICATOR	WALL CABINET
	48	1	SPARE NUMBER	SPARE NUMBER
	49	1	SPARE NUMBER	SPARE NUMBER
	50	1	PERLUCK	DROP-IN ICE CHEST
(VEND)	50.1	1	BY VENDOR	SODA GUN
	51	1	PERLUCK	BACKBAR REFRIGERATOR
	52	1	FABRICATOR	WORK COUNTER
	53	1	SPARE NUMBER	SPARE NUMBER
	54	1	SPARE NUMBER	SPARE NUMBER
	55	1	FABRICATOR	WALL CABINET
	56	1	SPARE NUMBER	SPARE NUMBER
	57	1	SPARE NUMBER	SPARE NUMBER
	58	1	SPARE NUMBER	SPARE NUMBER
	59	1	SPARE NUMBER	SPARE NUMBER
	60	1	FABRICATOR	PREP TABLE W/ SINK
	60.1	1	FABRICATOR	PREP SINK
	61	1	FABRICATOR	WALL SHELF
	62	1	ALTO-SHAAM	HOT HOLDING CABINET
	63	1	SPARE NUMBER	SPARE NUMBER
	64	1	SPARE NUMBER	SPARE NUMBER
	65	1	CONTINENTAL	FREEZER, UNDERCOUNTER, REACH-IN
	66	1	FRIGO	FRYER, GAS
	66.1	1	T&S BRASS	GAS CONNECTOR KIT
	67	1	VULCAN	RANGE, 36" HEAVY DUTY, GAS
	68	1	VULCAN	SALAMANDER BROILER, GAS
	69	1	SPARE NUMBER	SPARE NUMBER
	70	1	VULCAN	RANGE, 24" HEAVY DUTY, GAS
	71	1	VULCAN	RANGE, 12" HEAVY DUTY, GAS
	71.1	1	T&S BRASS	GAS CONNECTOR KIT
	72	1	SPARE NUMBER	SPARE NUMBER
	73	1	SPARE NUMBER	SPARE NUMBER
	74	1	SPARE NUMBER	SPARE NUMBER
	75	1	HALTON	EXHAUST HOOD
	75.1	1	ANUL	FIRE SUPPRESSION SYSTEM
	75.2	1	HALTON	HOOD CONTROL PANEL
	75.3	1	FABRICATOR	S/S WALL PANELS (LOT)
	76	1	FABRICATOR	CHEF UNIT
(OWN)	77	1	BY OWNER	POS - PRINTER
	78	1	SPARE NUMBER	SPARE NUMBER
	79	1	SPARE NUMBER	SPARE NUMBER
	80	1	TRAUlsen	REFRIGERATOR, REACH-IN
(OWN)	81	1	IMC TEDDY	HAND SINK
	81.1	1	BY OWNER	SOAP & TOWEL DISPENSER
	82	1	TRAUlsen	REFRIGERATOR, REACH-IN
	83	1	SPARE NUMBER	SPARE NUMBER
	84	1	SPARE NUMBER	SPARE NUMBER
	85	1	FABRICATOR	WORK COUNTER
	86	2	FROSTY FACTORY	FROZEN DRINK MACHINE - AIR COOLED
(OWN)	87	1	BY OWNER	POS - PRINTER
(OWN)	88	1	BY OWNER	POS - CASH REGISTER
	89	1	SPARE NUMBER	SPARE NUMBER
	90	1	SPARE NUMBER	SPARE NUMBER
	91	1	SPARE NUMBER	SPARE NUMBER
	92	1	SPARE NUMBER	SPARE NUMBER
	93	1	SPARE NUMBER	SPARE NUMBER
	94	1	SPARE NUMBER	SPARE NUMBER
	95	1	SPARE NUMBER	SPARE NUMBER
	96	1	SPARE NUMBER	SPARE NUMBER
	97	1	SPARE NUMBER	SPARE NUMBER
	98	1	SPARE NUMBER	SPARE NUMBER
	99	1	SPARE NUMBER	SPARE NUMBER
(OWN)	100	3	BY OWNER	POS - CASH REGISTER
(OWN)	101	3	BY OWNER	POS - PRINTER
	102	1	GLASTENDER	BACKBAR CABINET, REFRIGERATED
	103	1	SPARE NUMBER	SPARE NUMBER
	104	1	SPARE NUMBER	SPARE NUMBER
	105	1	GLASTENDER	BACKBAR CABINET, REFRIGERATED
	106	1	GLASTENDER	BACKBAR CABINET, REFRIGERATED
	107	1	GLASTENDER	BACKBAR CABINET, REFRIGERATED
	108	1	SPARE NUMBER	SPARE NUMBER
	109	1	SPARE NUMBER	SPARE NUMBER
	110	1	SPARE NUMBER	SPARE NUMBER
	111	1	GLASTENDER	MIXOLOGY UNIT
	112	1	GLASTENDER	UNDERBAR BOTTLE DISPLAY UNIT
	113	1	SPARE NUMBER	SPARE NUMBER
	114	1	SPARE NUMBER	SPARE NUMBER
	115	12	FABRICATOR	UNDERBAR FILLER STRIP
	116	1	GLASTENDER	ICE BIN/COCKTAIL STATION
	117	1	FABRICATOR	SCUPPER DRAIN
	118	1	SPARE NUMBER	SPARE NUMBER

PR	ITEM	QTY	SOURCE	DESCRIPTION
	119	1	SPARE NUMBER	SPARE NUMBER
	120	1	GLASTENDER	UNDERBAR ADD-ON UNIT
(VEND)	120.1	1	BY VENDOR	SODA GUN & CARBONATOR
	121	1	GLASTENDER	UNDERBAR DRAIN WORKBOARD UNIT
	122	1	GLASTENDER	UNDERBAR DRY WASTE UNIT
	123	1	SPARE NUMBER	SPARE NUMBER
	124	1	SPARE NUMBER	SPARE NUMBER
	125	1	GLASTENDER	UNDERBAR HAND SINK
	126	1	GLASTENDER	UNDERBAR BOTTLE DISPLAY UNIT
	127	1	SPARE NUMBER	SPARE NUMBER
	128	1	SPARE NUMBER	SPARE NUMBER
	129	1	GLASTENDER	ICE BIN/COCKTAIL STATION
	130	1	FABRICATOR	SCUPPER DRAIN
	131	1	GLASTENDER	UNDERBAR ADD-ON UNIT
(VEND)	131.1	1	BY VENDOR	SODA GUN & CARBONATOR
	132	1	GLASTENDER	UNDERBAR DRAIN WORKBOARD UNIT
	133	1	SPARE NUMBER	SPARE NUMBER
	134	1	SPARE NUMBER	SPARE NUMBER
	135	1	GLASTENDER	UNDERBAR BOTTLE DISPLAY UNIT
	136	1	GLASTENDER	ICE BIN/COCKTAIL STATION
	137	1	FABRICATOR	SCUPPER DRAIN
	138	1	SPARE NUMBER	SPARE NUMBER
	139	1	SPARE NUMBER	SPARE NUMBER
	140	1	GLASTENDER	UNDERBAR ADD-ON UNIT
(VEND)	140.1	1	BY VENDOR	SODA GUN & CARBONATOR
	141	1	GLASTENDER	UNDERBAR DRAIN WORKBOARD UNIT
	142	1	GLASTENDER	UNDERBAR DRY WASTE UNIT
	143	1	SPARE NUMBER	SPARE NUMBER
	144	1	SPARE NUMBER	SPARE NUMBER
	145	1	GLASTENDER	MIXOLOGY UNIT
	146	1	HOBART	DISHWASHER, UNDERCOUNTER
	147	1	SPARE NUMBER	SPARE NUMBER
	148	1	SPARE NUMBER	SPARE NUMBER
	149	1	SPARE NUMBER	SPARE NUMBER
	150	1	SPARE NUMBER	SPARE NUMBER
	151	1	SPARE NUMBER	SPARE NUMBER
	152	1	SPARE NUMBER	SPARE NUMBER
	153	1	SPARE NUMBER	SPARE NUMBER
	154	1	SPARE NUMBER	SPARE NUMBER
	155	1	SPARE NUMBER	SPARE NUMBER
	156	1	SPARE NUMBER	SPARE NUMBER
	157	1	SPARE NUMBER	SPARE NUMBER
	158	1	SPARE NUMBER	SPARE NUMBER
	159	1	SPARE NUMBER	SPARE NUMBER
	160	1	SPARE NUMBER	SPARE NUMBER
	161	1	SPARE NUMBER	SPARE NUMBER
	162	1	SPARE NUMBER	SPARE NUMBER
	163	1	SPARE NUMBER	SPARE NUMBER
	164	1	SPARE NUMBER	SPARE NUMBER
	165	1	SPARE NUMBER	SPARE NUMBER
	166	1	SPARE NUMBER	SPARE NUMBER
	167	1	SPARE NUMBER	SPARE NUMBER
	168	1	SPARE NUMBER	SPARE NUMBER
	169	1	SPARE NUMBER	SPARE NUMBER
	170	1	GLASTENDER	UNDERBAR DRAIN WORKBOARD UNIT
	171	1	GLASTENDER	UNDERBAR ADD-ON UNIT
(VEND)	171.1	1	BY VENDOR	SODA GUN & CARBONATOR
	172	1	FABRICATOR	SCUPPER DRAIN
	173	1	SPARE NUMBER	SPARE NUMBER
	174	1	SPARE NUMBER	SPARE NUMBER
	175	1	GLASTENDER	ICE BIN/COCKTAIL STATION
	176	1	GLASTENDER	UNDERBAR BOTTLE DISPLAY UNIT
	177	1	GLASTENDER	UNDERBAR DRY WASTE UNIT
	178	1	SPARE NUMBER	SPARE NUMBER
	179	1	SPARE NUMBER	SPARE NUMBER
	180	1	GLASTENDER	UNDERBAR MIXOLOGY SINK UNIT
	181	1	GLASTENDER	UNDERBAR HAND SINK
	182	1	HOBART	DISHWASHER, UNDERCOUNTER
	183	1	SPARE NUMBER	SPARE NUMBER
	184	1	SPARE NUMBER	SPARE NUMBER
	185	1	GLASTENDER	UNDERBAR DRAIN WORKBOARD UNIT
	186	1	GLASTENDER	UNDERBAR ADD-ON UNIT
(VEND)	186.1	1	BY VENDOR	SODA GUN & CARBONATOR
	187	1	FABRICATOR	SCUPPER DRAIN
	188	1	SPARE NUMBER	SPARE NUMBER
	189	1	SPARE NUMBER	SPARE NUMBER
	190	1	GLASTENDER	ICE BIN/COCKTAIL STATION
	191	1	GLASTENDER	UNDERBAR BOTTLE DISPLAY UNIT
	192	1	GLASTENDER	UNDERBAR MIXOLOGY SINK UNIT
	193	1	SPARE NUMBER	SPARE NUMBER
	194	1	SPARE NUMBER	SPARE NUMBER
	195	1	GLASTENDER	UNDERBAR DRY WASTE UNIT
	196	1	GLASTENDER	UNDERBAR DRAIN WORKBOARD UNIT
	197	1	GLASTENDER	UNDERBAR ADD-ON UNIT
(VEND)	197.1	1	BY VENDOR	SODA GUN & CARBONATOR
	198	1	SPARE NUMBER	SPARE NUMBER
	199	1	SPARE NUMBER	SPARE NUMBER
	200	1	FABRICATOR	SCUPPER DRAIN
	201	1	GLASTENDER	ICE BIN/COCKTAIL STATION
	202	1	GLASTENDER	UNDERBAR BOTTLE DISPLAY UNIT
	203	1	SPARE NUMBER	SPARE NUMBER
	204	1	SPARE NUMBER	SPARE NUMBER
	205	1	GLASTENDER	UNDERBAR MIXOLOGY SINK UNIT
	206	1	SPARE NUMBER	SPARE NUMBER
	207	1	SPARE NUMBER	SPARE NUMBER
	208	1	SPARE NUMBER	SPARE NUMBER
	209	1	SPARE NUMBER	SPARE NUMBER
	210	1	GLASTENDER	BACKBAR CABINET, REFRIGERATED
(OWN)	211	3	BY OWNER	POS - PRINTER
(OWN)	212	3	BY OWNER	POS - CASH REGISTER
	213	1	SPARE NUMBER	SPARE NUMBER
	214	1	SPARE NUMBER	SPARE NUMBER
	215	1	GLASTENDER	BACKBAR CABINET, REFRIGERATED
	216	1	CHILL-RITE	DRAFT BEER DISPENSER TOWER
	217	1	GLASTENDER	BACKBAR CABINET, REFRIGERATED
	218	1	SPARE NUMBER	SPARE NUMBER
	219	1	SPARE NUMBER	SPARE NUMBER
	220	1	GLASTENDER	BACKBAR CABINET, REFRIGERATED
	221	1	SPARE NUMBER	SPARE NUMBER
	222	1	SPARE NUMBER	SPARE NUMBER
	223	1	SPARE NUMBER	SPARE NUMBER
	224	1	SPARE NUMBER	SPARE NUMBER
	225	1	SPARE NUMBER	SPARE NUMBER
	226	1	SPARE NUMBER	SPARE NUMBER
	227	1	SPARE NUMBER	SPARE NUMBER
	228	1	SPARE NUMBER	SPARE NUMBER
	229	1	SPARE NUMBER	SPARE NUMBER
	230	2	METRO	SECURITY UNIT
	231	1	FABRICATOR	FLOOR TROUGH
	232	1	FOLLETT	ICE BIN SHUTTLE SYSTEM
	232.1	1	SAN JAMAR	ICE SCOOP HOLDER
	233	1	SPARE NUMBER	SPARE NUMBER
	234	1	SPARE NUMBER	SPARE NUMBER
	235	1	HOSHIZAKI	ICE MAKER, CUBE STYLE
	236	1	HOSHIZAKI	ICE MAKER, CUBE STYLE
	237	1	FOLLETT	ICE BIN SHUTTLE SYSTEM
	237.1	1	SAN JAMAR	ICE SCOOP HOLDER
	238	1	SPARE NUMBER	SPARE NUMBER
	239	1	SPARE NUMBER	SPARE NUMBER
	240	1	HOSHIZAKI	ICE MAKER, CUBE STYLE
	241	1	HOSHIZAKI	ICE MAKER, CUBE STYLE
	242	4	CAMBRO	ICE BIN, MOBILE
	243	1	SPARE NUMBER	SPARE NUMBER

PR	ITEM	QTY	SOURCE	DESCRIPTION
	244	1	SPARE NUMBER	SPARE NUMBER
	245	1	EVERPURE	WATER FILTER ASSEMBLY
	246	1	EVERPURE	WATER FILTER ASSEMBLY
	247	1	FABRICATOR	WORK COUNTER
	248	1	FABRICATOR	WALL CABINET
	249	1	SPARE NUMBER	SPARE NUMBER
	250	1	PERLUCK	BACKBAR REFRIGERATOR
	251	1	PERLUCK	DROP-IN ICE CHEST
(VEND)	251.1	1	BY VENDOR	SODA GUN
	252	1	FABRICATOR	WORK TABLE
	253	1	SPARE NUMBER	SPARE NUMBER
	254	1	SPARE NUMBER	SPARE NUMBER
	255	1	FABRICATOR	WALL CABINET
	256	3	METRO	DOLLY, DISHWASHER RACK
	257	1	ADVANCE TABCO	MOP SINK CABINET
	258	1	SPARE NUMBER	SPARE NUMBER
	259	1	SPARE NUMBER	SPARE NUMBER
	260	1	METRO	DRY STORAGE SHELVING (LOT)
	261	1	SPARE NUMBER	SPARE NUMBER
	262	1	SPARE NUMBER	SPARE NUMBER
	263	1	SPARE NUMBER	SPARE NUMBER
	264	1	SPARE NUMBER	SPARE NUMBER
	265	1	THERMOKOOL	WALK-IN COOLER
	265.1	1	COLDZONE	EVAPORATOR COIL
	265.2	1	COLDZONE	CONDENSING UNIT, WATER COOLED
	266	1	METRO	WALK-IN SHELVING (LOT)
	267	1	NEW AGE	KEG RACK
	268	1	SPARE NUMBER	SPARE NUMBER
	269	1	SPARE NUMBER	SPARE NUMBER
	270	1	CHILL-RITE	BEER LINE CHILLER
(VEND)	271	1	BY VENDOR	SODA BAG-N-BOX SYSTEM
	271.1	1	EVERPURE	WATER FILTER ASSEMBLY
	272	1	SPARE NUMBER	SPARE NUMBER
	273	1	SPARE NUMBER	SPARE NUMBER
	274	1	SPARE NUMBER	SPARE NUMBER
	275	1	SPARE NUMBER	SPARE NUMBER
	276	1	SPARE NUMBER	SPARE NUMBER
	277	1	SPARE NUMBER	SPARE NUMBER
	278	1	SPARE NUMBER	SPARE NUMBER
	279	1	SPARE NUMBER	SPARE NUMBER
	280	1	METRO	DOLLY, DISHWASHER RACK
	281	7	METRO	STEM CASTER CART
(OWN)	282	1	IMC TEDDY	HAND SINK
	282.1	1	BY OWNER	SOAP & TOWEL DISPENSER
	283	1	SPARE NUMBER	SPARE NUMBER
	284	1	SPARE NUMBER	SPARE NUMBER
	285	1	FABRICATOR	CLEAN DISH TABLE
	286	1	FABRICATOR	WALL SHELF
	287	1	HATCO	BOOSTER HEATER, ELECTRIC
	288	1	SPARE NUMBER	SPARE NUMBER
	289	1	SPARE NUMBER	SPARE NUMBER
	290	1	CAPTIVE-AIRE	CONDENSATE HOOD
	291	1	HOBART	DISHWASHER, CONVEYOR TYPE
	292	1	INSINKERATOR	GARBAGE DISPOSER
	293	1	SPARE NUMBER	SPARE NUMBER
	294	1	SPARE NUMBER	SPARE NUMBER
	295	1	FABRICATOR	SOILED DISH TABLE
	295.1	1	T&S BRASS	PRE-RINSE FAUCET ASSEMBLY
	296	15	FABRICATOR	CORNER GUARDS
	297	2	SPARE NUMBER	SPARE NUMBER
	299	1	SPARE NUMBER	SPARE NUMBER
	300	1	SPARE NUMBER	SPARE NUMBER
	301	1	TRAULEN	REFRIGERATOR, REACH-IN
	302	1	TRAULEN	REFRIGERATOR, REACH-IN
	303	1	SPARE NUMBER	SPARE NUMBER
	304	1	SPARE NUMBER	SPARE NUMBER
	305	1	FABRICATOR	WALL CABINET
	306	1	FABRICATOR	BEVERAGE COUNTER
	307	1	PERLUCK	DROP-IN ICE CHEST
(VEND)	307.1	1	BY VENDOR	SODA GUN
	308	2	CAMBRO	ICE BIN, MOBILE
(VEND)	309	1	PERLUCK	DROP-IN ICE CHEST
(VEND)	309.1	1	BY VENDOR	SODA GUN
	310	1	PERLUCK	BACKBAR REFRIGERATOR
	311	1	FABRICATOR	WALL CABINET
	312	1	FABRICATOR	WORK COUNTER
	313	1	SPARE NUMBER	SPARE NUMBER
	314	1	SPARE NUMBER	SPARE NUMBER
	315	1	ONNITEMP	HAND SINK W/ SOAP & TOWEL DISPENSER
	316	9	METRO	DOLLY, DISHWASHER RACK
	317	2	METRO	SECURITY UNIT
	318	2	CAMBRO	ICE BIN, MOBILE
	319	1	SPARE NUMBER	SPARE NUMBER
	320	1	IMC TEDDY	FLOOR TROUGH
	321	1	FOLLETT	ICE BIN SHUTTLE SYSTEM
	321.1	1	SAN JAMAR	ICE SCOOP HOLDER
	322	2	HOSHIZAKI	ICE MAKER, CUBE STYLE
	323	1	SPARE NUMBER	SPARE NUMBER
	324	1	SPARE NUMBER	SPARE NUMBER
	325	1	EVERPURE	WATER FILTER ASSEMBLY
	326	1	SPARE NUMBER	SPARE NUMBER
	327	1	SPARE NUMBER	SPARE NUMBER
	328	2	METRO	SECURITY UNIT
	329	1	TRAULEN	REFRIGERATOR, REACH-IN
(VEND)	330	1	BY VENDOR	SODA BAG-N-BOX SYSTEM
	330.1	1	EVERPURE	WATER FILTER ASSEMBLY
	331	1	GLASTENDER	BACKBAR CABINET, REFRIGERATED
	332	1	FABRICATOR	CUSTOM DRAINBOARD
	333	1	SPARE NUMBER	SPARE NUMBER
	334	1	SPARE NUMBER	SPARE NUMBER
	335	1	GLASTENDER	UNDERBAR DRY WASTE UNIT
	336	1	GLASTENDER	UNDERBAR MIKOLOGY SINK UNIT
	337	1	GLASTENDER	UNDERBAR BOTTLE DISPLAY UNIT
	338	1	GLASTENDER	ICE BIN/COCKTAIL STATION
(VEND)	339	1	GLASTENDER	SODA GUN HOLDER
	339.1	1	BY VENDOR	SODA GUN & CARBONATOR
	340	1	GLASTENDER	UNDERBAR DRAIN WORKBOARD UNIT
	341	1	HOBART	DISHWASHER, UNDERCOUNTER
	342	1	GLASTENDER	UNDERBAR HAND SINK
	343	1	SPARE NUMBER	SPARE NUMBER
	344	1	SPARE NUMBER	SPARE NUMBER
	345	1	GLASTENDER	UNDERBAR DRY WASTE UNIT
	346	1	GLASTENDER	UNDERBAR MIKOLOGY SINK UNIT
	347	1	GLASTENDER	UNDERBAR BOTTLE DISPLAY UNIT
	348	1	GLASTENDER	ICE BIN/COCKTAIL STATION
(VEND)	349	1	GLASTENDER	SODA GUN HOLDER
	349.1	1	BY VENDOR	SODA GUN & CARBONATOR
	350	1	GLASTENDER	UNDERBAR DRAIN WORKBOARD UNIT
	351	1	FABRICATOR	CUSTOM DRAINBOARD
	352	1	FABRICATOR	SCUPPER DRAIN
	353	1	SPARE NUMBER	SPARE NUMBER
	354	1	SPARE NUMBER	SPARE NUMBER
	355	1	FABRICATOR	SCUPPER DRAIN
(OWN)	356	1	BY OWNER	POS - PRINTER
(OWN)	357	1	BY OWNER	POS - CASH REGISTER
	358	1	GLASTENDER	BACKBAR CABINET, REFRIGERATED
	359	1	CHILL-RITE	BEER DISPENSING TOWER HEAD UNIT
	360	1	GLASTENDER	BACKBAR CABINET, REFRIGERATED
	361	1	SPARE NUMBER	SPARE NUMBER
	362	1	SPARE NUMBER	SPARE NUMBER
	363	1	SPARE NUMBER	SPARE NUMBER
	364	1	SPARE NUMBER	SPARE NUMBER
	365	1	GLASTENDER	BACKBAR CABINET, REFRIGERATED
	366	1	GLASTENDER	BACKBAR CABINET, REFRIGERATED