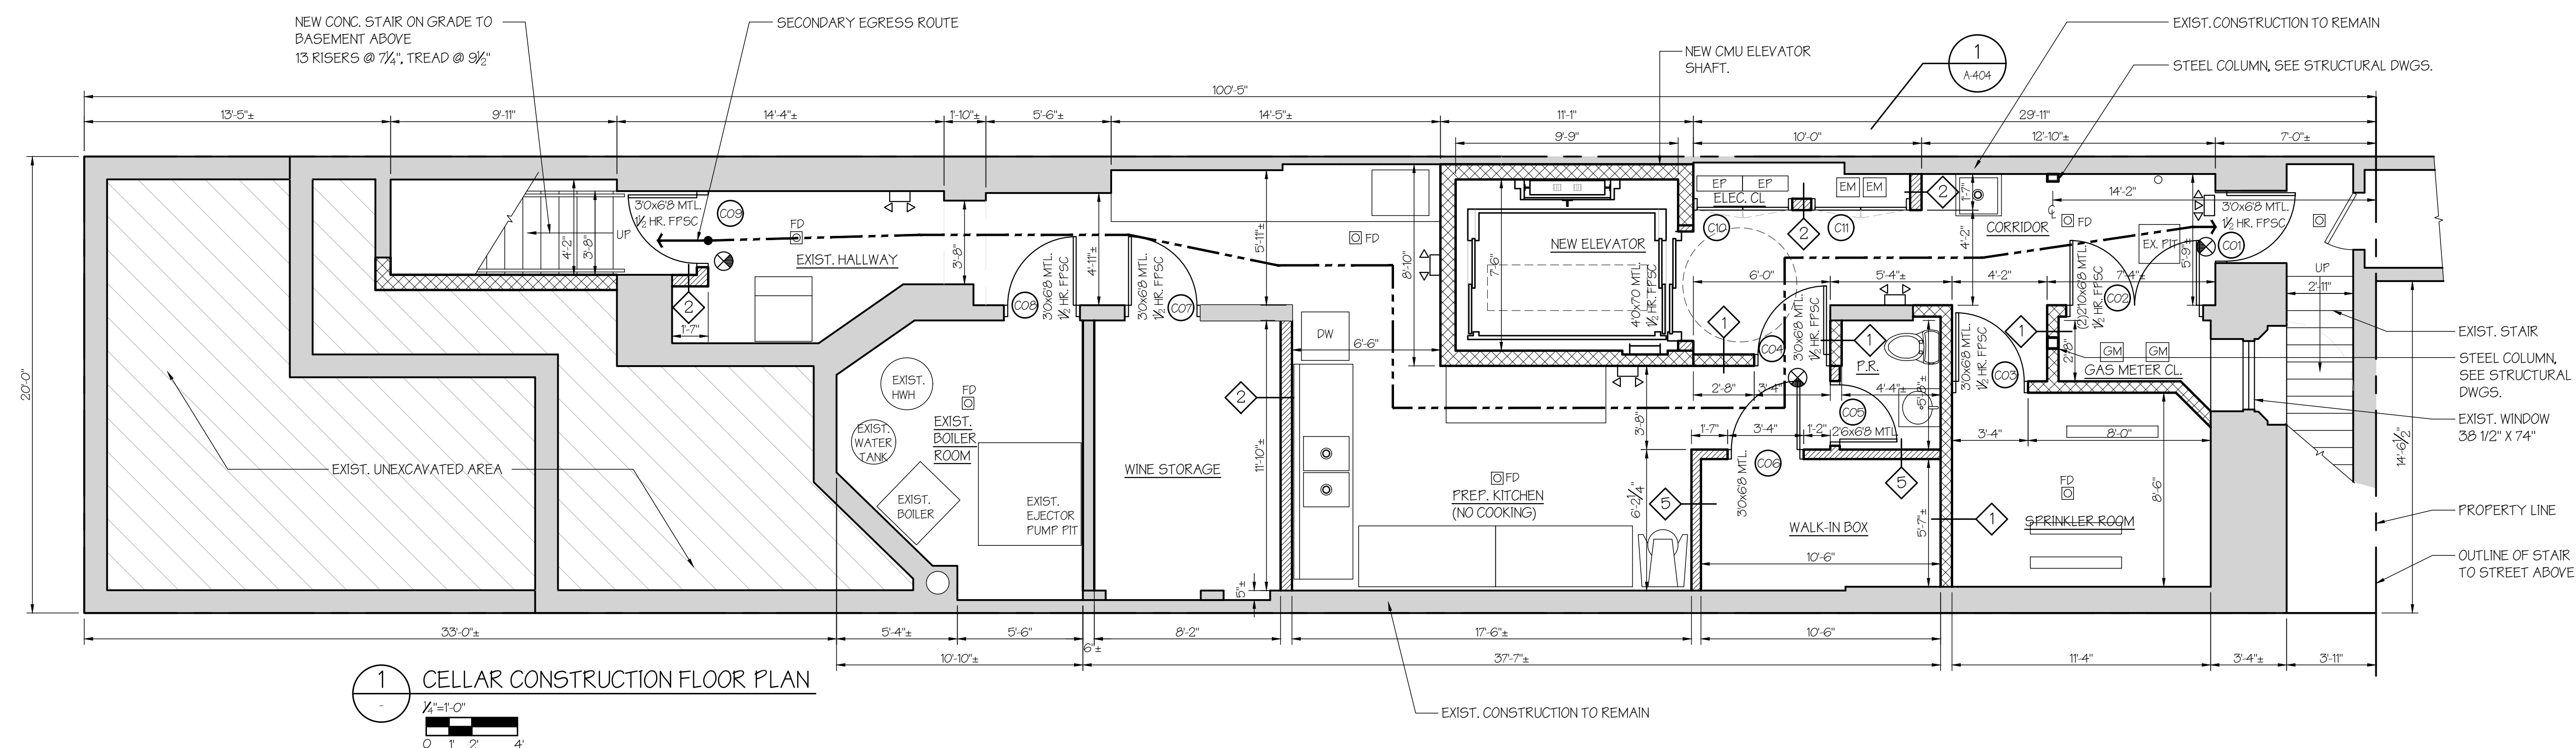


1. ALL JOIST WILL BE ONE HOUR PROTECTED.
2. STAIR HALL & SHAFTS WILL BE TWO HOUR PROTECTED.
3. BUILDING WILL BE FULLY SPRINKLERED THROUGHOUT.
4. A FIRE ALARM SYSTEM WILL BE PROVIDED WITHIN THE BUILDING.
5. A NEW STEEL STAIR WILL BE PROVIDED TO REPLACE EXIST. WOOD STAIR FROM GROUND FLOOR TO ROOF.

	EXISTING CONSTRUCTION
	NEW PARTITION
	NEW CMU PARTITION
	LINE OF CONSTRUCTION ABOVE
	WALL PARTITION TYPE
	EXISTING DOOR
	NEW DOOR
	EXIT SIGN
	EMERGENCY LIGHT W/BATTERY BACKUP

[illegible]

Frank Nigro ARCHITECT, P.C.
25 WEST 83RD ST
NEW YORK, NY 10024
T 212.206.6600
F 212.206.6655

B G M
ENGINEERING, LLC
2123 45TH ROAD, LONG ISLAND CITY, NY 11106
24 CANFIELD DRIVE STAMFORD, CT 06902
TEL: 203.452.9408 and 846.499.0685
E-MAIL: info@bgmengineer.com

JMV CONSULTING ENGINEERING, P.C.

37 West 39th Street, Suite 703
New York, NY 10018
Phone: 212-852-9855
Fax: 212-278-8922
www.jmvengineering.com

Project

BUILDING RENOVATION
& RESTAURANT EXPANSION

33 WEST 54TH STREET
NEW YORK, NY 10019

Title _____

CELLAR & BASEMENT CONSTRUCTION PLANS

DATE _____
PROJECT NO. - _____
DRAWN BY _____
SCALE AS NOTED _____
DRAWING _____

A-100.00

